


PAVEMENT STRIPING LEGEND

SWSL/4" = 4" SINGLE WHITE SOLID LINE
 SWDL/4" = 4" SINGLE WHITE DASHED LINE
 DYSL/4" = 4" DOUBLE YELLOW SOLID LINE
 SYSL/4" = 4" SINGLE YELLOW SOLID LINE

THIS PLAN TO BE UTILIZED FOR SITE
LAYOUT PURPOSES ONLY

SIGNATURE	DATE
SIGNATURE	DATE
SIGNATURE	DATE
SIGNATURE	DATE
SIGNATURE	DATE

PAVEMENT LEGEND	
	HEAVY DUTY ASPHALT PAVEMENT
	STANDARD DUTY PAVEMENT

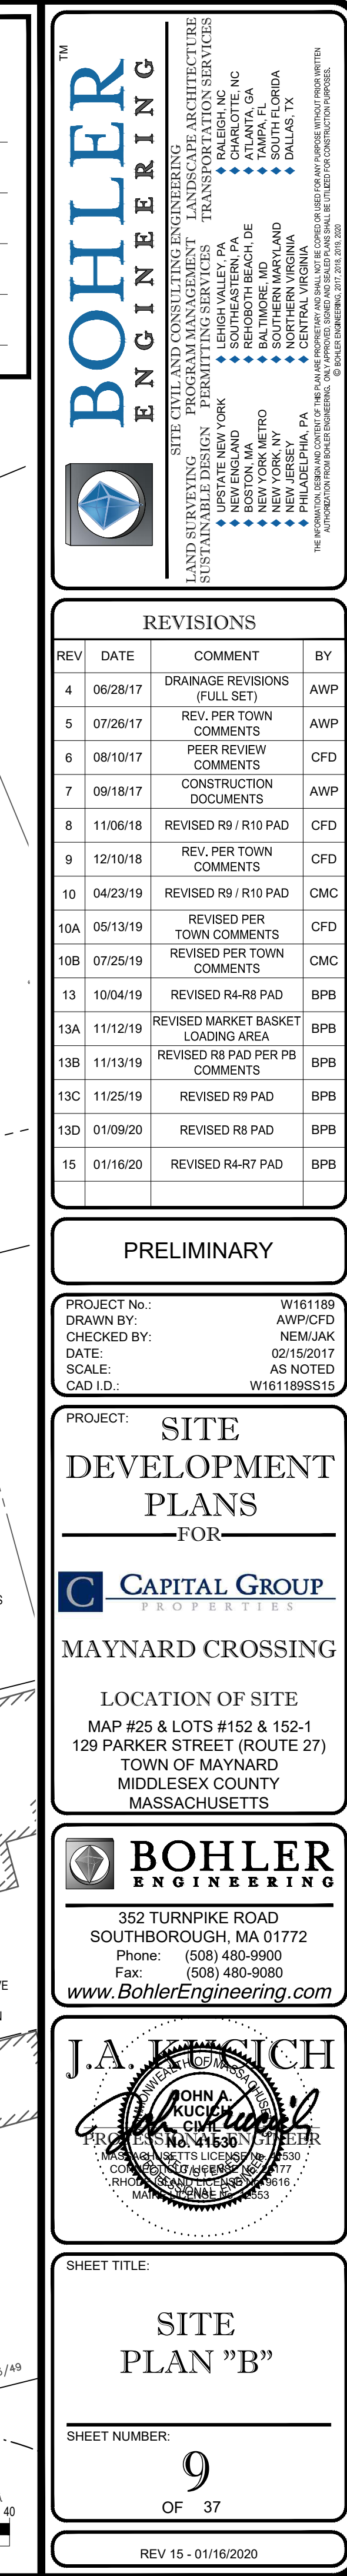

**Know what's below.
Call before you dig.**

SHEET NUMBER: 9 OF 10

REV 15 - 01/16/2020

CONTRACTOR SHALL INSTALL ADA RAMP
SUCH THAT BOTTOM OF RAMP
LANDINGS PROVIDE POSITIVE
DRAINAGE AND NOT LOW POINTS
SUSCEPTIBLE TO PONDING

GENERAL CONTRACTOR TO ENSURE ALL SIDEWALKS ARE
ADA/AAB COMPLIANT WITH 2% MAXIMUM CROSS SLOPES
AND 5% MAXIMUM RUNNING SLOPES. CONTRACTOR
SHALL ALSO ENSURE ALL RAMP ARE ADA/AAB
COMPLIANT IN ACCORDANCE WITH RAMP DETAILS ON
CONSTRUCTION DETAIL SHEETS. IF MORE INFORMATION
IS NEEDED IN CERTAIN AREAS, CONTRACTOR SHALL
SUBMIT AN RFI FOR CLARIFICATION.

FOR PIPE WITHIN 10 FT. OF BUILDING, PIPE MATERIAL SHALL
COMPLY WITH APPLICABLE BUILDING AND PLUMBING CODES.
CONTRACTOR TO VERIFY WITH LOCAL OFFICIALS.

REFER TO ARCH. PLANS FOR DETAIL OF BUILDING
SURROUND INCLUDING SIDEWALKS AND ADA RAMP.
COORDINATE CONNECTION OF ADA RAMP TO ACCESSIBLE
SPACES AND MAINTAIN 2% MAXIMUM SLOPE IN ALL
DIRECTIONS IN ACCESSIBLE PARKING SPACE AND ACCESS
AISLE AREAS. REFER TO ADA NOTES ON SHEET 2.

THIS PLAN TO BE UTILIZED FOR SITE
GRADING PURPOSES ONLY

REFER TO GENERAL NOTES SHEET
FOR GRADING & UTILITY NOTES

REFER TO SHEET 16 FOR
STORM DRAINAGE TABLE

TOWN OF MAYNARD PLANNING BOARD APPROVAL

SIGNATURE	DATE
SIGNATURE	DATE
SIGNATURE	DATE
SIGNATURE	DATE
SIGNATURE	DATE

BOHLER ENGINEERING

SITE PLANNING, SURVEYING, ENGINEERING, LANDSCAPE ARCHITECTURE
LAND SURVEYING, PROGRAM MANAGEMENT, PERMITTING SERVICES, TRANSPORTATION SERVICES
SUSTAINABLE DESIGN, PROJECT MANAGEMENT, FULL-SCALE DESIGN, URBAN DESIGN, TRAFFIC ENGINEERING, ENVIRONMENTAL ENGINEERING, GEOTECHNICAL ENGINEERING, HYDROLOGICAL ENGINEERING, CIVIL ENGINEERING, ELECTRICAL ENGINEERING, MECHANICAL ENGINEERING, PLUMBING ENGINEERING, CONSTRUCTION MANAGEMENT, CONSTRUCTION INSPECTION, CONSTRUCTION ADMINISTRATION, CONSTRUCTION DOCUMENTS, CONSTRUCTION SCHEDULING, CONSTRUCTION COST ESTIMATING, CONSTRUCTION RISK MANAGEMENT, CONSTRUCTION CLAIMS MANAGEMENT, CONSTRUCTION LITIGATION, CONSTRUCTION MEDIATION, CONSTRUCTION ARBITRATION, CONSTRUCTION ADJUDICATION, CONSTRUCTION DISPUTE RESOLUTION, CONSTRUCTION RISK TRANSFER, CONSTRUCTION RISK MITIGATION, CONSTRUCTION RISK REDUCTION, CONSTRUCTION RISK AVOIDANCE, CONSTRUCTION RISK TRANSFER, CONSTRUCTION RISK MITIGATION, CONSTRUCTION RISK REDUCTION, CONSTRUCTION RISK AVOIDANCE

25-09
ALAYNA MULLER, P.E.
REGISTERED PROFESSIONAL ENGINEER
MAYNARD, MA 01954

REV	DATE	COMMENT	BY
4	06/28/17	DRAINAGE REVISIONS	AWP
5	07/26/17	REV. PER TOWN COMMENTS	AWP
6	08/10/17	PEER REVIEW COMMENTS	CFD
7	09/18/17	CONSTRUCTION DOCUMENTS	AWP
8	11/06/18	REVISED R9 / R10 PAD	CFD
9	12/10/18	REV. PER TOWN COMMENTS	CFD
10	04/23/19	REVISED R9 / R10 PAD	CMC
10A	05/13/19	REVISED PER TOWN COMMENTS	CFD
10B	07/25/19	REVISED PER TOWN COMMENTS	CMC
11	10/04/19	REVISED R4-R8 PAD	BPB
13A	11/12/19	REVISED MARKET BASKET LOADING AREA	BPB
13B	11/13/19	REVISED R8 PAD PER BPB COMMENTS	BPB
13C	11/25/19	REVISED R8 PAD	BPB
13D	01/09/20	REVISED R8 PAD	BPB
15	01/16/20	REVISED R4-R7 PAD	BPB

PRELIMINARY

PROJECT No.: W161189
DRAWN BY: AWP/CFD
CHECKED BY: NEW/JAK
DATE: 02/15/2017
SCALE: AS NOTED
CAD I.D.: W161189S15

SITE DEVELOPMENT PLANS FOR

CAPITAL GROUP
PROPERTIES
MAYNARD CROSSING

LOCATION OF SITE
MAP #25 & LOTS #152 & 152-1
129 PARKER STREET (ROUTE 27)
TOWN OF MAYNARD
MIDDLESEX COUNTY
MASSACHUSETTS

BOHLER ENGINEERING
352 TURNPIKE ROAD
SOUTHBOROUGH, MA 01772
Phone: (508) 480-9900
Fax: (508) 480-9980
www.BohlerEngineering.com

J.A. KUCICH
JOHN A. KUCICH, P.E.
REGISTERED PROFESSIONAL ENGINEER
MAYNARD, MA 01954
MASSACHUSETTS REG. NO. 41530
EXPIRATION DATE: 12/31/2024

GRADING & DRAINAGE PLAN "B"

SHEET NUMBER:
13
OF 37
REV 15 - 01/16/2020

P:\161189\161189-Crossing\Plan_Sheet\REV15\W161189S15.dwg, 13-04.dwg, B, 03/02/2024, 4:26:00 PM, bharry, Xerox510-15-04, User:541, 1:000000027



Know what's below.
Call before you dig.

NOTES:
PIPE LENGTHS ARE MEASURED CENTER TO CENTER
PIPE MATERIAL IS TO BE HDPE UNLESS SPECIFIED OTHERWISE. REFER TO GENERAL NOTES
ON SHEET 2 FOR MORE INFORMATION.

* DENOTES DRAINAGE STRUCTURES ASSOCIATED WITH THE LECESSE AND HAWTHORNE
DEVELOPMENTS THAT ARE NOT INCLUDED WITH THE CURRENT CONSTRUCTION.

WQU-1A/1B IS A VORTECHNICS MODEL 4000
WQU-2A/2B IS A VORTECHNICS MODEL 5000
CB33 IS A DOUBLE GRATE CATCH BASIN
WDIV1-A/B IS THE DIVERSION STRUCTURE FOR WQU-1A
WDIV2-A/B IS THE DIVERSION STRUCTURE FOR WQU-2A
**REFER TO DETAIL SHEET 30 FOR MORE INFORMATION

- (1) STRUCTURE WAS FIELD ADJUSTED BY CONTRACTOR
(2) REVISED PER CONSTRUCTION SK#2
(3) REVISED PER CONSTRUCTION SK#3
(4) ROOF LEADER CONNECTION TO BE CORED BY
CONTRACTOR AFTER STRUCTURE INSTALLED,
COORDINATE WITH MASTER DEVELOPER

TOWN OF MAYNARD PLANNING BOARD APPROVAL


SIGNATURE	DATE
SIGNATURE	DATE
SIGNATURE	DATE
SIGNATURE	DATE

DRAINAGE TABLE						
STR.	RIM GRT	INV. IN	INV. OUT	OUT. PIPE SIZE	PIPE LENGTH	OUT. PIPE SLOPE
B4*		194.50(CB-71*)		8"	4'	0.00%
B5*		194.50(CB-88*)		8"	9'	0.00%
B6*		194.50(CB-74*)		8"	4'	0.00%
B9*		194.50(CB-78*)		8"	11'	0.00%
B10*		194.50(CB-79*)		8"	9'	0.00%
B11A*		194.50(CB-80*)		8"	7'	0.00%
B11B*		194.50(BND-6*)		8"	3'	0.00%
B12A		195.50(CB-82)		8"	23'	0.00%
B12B		195.50(CB-83)		8"	9'	0.00%
BND-1*		194.50(CB-73*)	194.50(BND-2*)	8"	3'	0.00%
BND-2*		194.50(BND-1*)	194.50(TEE-1*)	8"	51'	0.00%
BND-3*		193.50(BND-4*)	193.50(MH-87*)	8"	17'	0.00%
BND-4*		193.50(CB-76*)	193.50(BND-3*)	8"	11'	0.00%
BND-5*		194.50(BND-6*)	194.50(CB-81*)	8"	18'	0.00%
BND-6*		194.50(B11B*)	194.50(BND-5*)	8"	3'	0.00%
BND-7*		195.76(R3A*)	195.76(BND-8*)	12"	12'	0.51%
BND-8*		195.70(BND-7*)	195.70(BND-9*)	12"	235'	0.00%
BND-9*		195.70(BND-8*)	195.70(BND-10*)	12"	14'	0.00%
BND-10*		195.70(BND-9*)	195.70(MH-L3A*)	12"	73'	0.00%
BND-11*		195.70(BND-12*)	195.70(MH-L3A*)	12"	49'	0.00%
BND-12*		195.70(BND-13*)	195.70(BND-11*)	12"	21'	0.00%
BND-13*		195.70(BND-14*)	195.70(BND-12*)	12"	71'	0.00%
BND-14*		195.81(MH-L2*)	195.81(BND-13*)	12"	21'	0.52%
BND-15*		195.68(BND-16*)	195.68(MH-L2*)	12"	143'	0.49%
BND-16*		196.71(R3G*)	196.71(BND-15*)	12"	6'	0.49%
BND-17*		196.05(R1H*)	196.05(BND-18*)	12"	5'	1.11%
BND-18*		196.00(BND-17*)	196.00(MH-W3*)	12"	142'	0.00%
BND-19*		196.53(R1E*)	196.53(BND-20*)	12"	3'	0.91%
BND-20*		196.50(BND-19*)	196.50(MH-L1A*)	12"	134'	0.00%
BND-21*		196.58(R1C*)	196.58(BND-22*)	8"	9'	0.93%
BND-22*		196.50(BND-21*)	195.50(MH-L1A*)	12"	52'	0.00%
BND-23*		196.50(BND-24*)	195.50(MH-L1A*)	12"	29'	0.00%
BND-24*		196.60(R1B*)	196.60(BND-23*)	8"	10'	1.03%
BND-25*		196.60(R1A*)	196.60(BND-26*)	8"	10'	1.03%
BND-26*		196.50(BND-25*)	196.50(MH-L1A*)	12"	33'	0.00%
BND-27*		196.50(BND-28*)	196.50(MH-L1A*)	12"	46'	0.00%
BND-28*		196.59(R1L*)	196.59(BND-27*)	8"	9'	0.97%
BND-29		197.00(RBB-T)	197.00(MH-S)	12"	16'	0.00%
BND-30		200.24(R1D)	200.24(MH-A6)	12"	135'	0.50%
BND-31		200.32(R2A)	200.32(MH-B1A)	12"	455'	0.40%
BND-32		199.75(BND-34)	199.75(MH-W2)	12"	250'	0.00%
--	--	--	--	--	--	--
BND-34		199.79(BND-35)	199.79(BND-32)	12"	8'	0.51%
BND-35		200.50(R3E)	200.50(BND-34)	12"	178'	0.40%
CB-1	201.60		199.10(MH-A4)	12"	123'	0.50%
CB-1A	201.60		196.63(MH-A4)	12"	7'	1.96%
CB-2	201.70		196.24(MH-A)	12"	7'	1.96%
CB-2A	201.50		196.50(MH-B1)	12"	7'	1.96%
CB-3	201.65		197.05(MH-B)	12"	71'	0.99%
CB-4	201.14		197.00(MH-Q2)	12"	9'	1.09%
CB-5	201.80		198.00(MH-C)	12"	20'	1.68%
CB-6	199.00		195.50(MH-D)	18"	11'	2.00%
CB-7	199.15		195.38(MH-D)	18"	137'	0.50%
CB-8	199.00		195.50(MH-E)	12"	11'	2.00%
CB-9	199.00		196.22(MH-E)	18"	144'	0.50%
CB-10	199.50		195.50(MH-F)	12"	14'	0.98%
CB-11	201.20		197.16(MH-J)	15"	165'	0.50%

DRAINAGE TABLE						
STR.	RIM GRT	INV. IN	INV. OUT	OUT. PIPE SIZE	PIPE LENGTH	OUT. PIPE SLOPE
CB-12	201.60		198.00(MH-J)	12"	9'	2.01%
CB-13	201.80		197.50(MH-K)	18"	15'	2.00%
CB-14	201.55		197.00(MH-K)	12"	123'	1.00%
CB-15	201.80		196.17(MH-L)	12"	16'	1.00%
CB-16	201.00		197.00(MH-M)	12"	25'	2.00%
CB-17	199.80		195.80(MH-N4)	12"	36'	2.00%
CB-18	200.30		196.63(MH-N1)	12"	8'	1.00%
CB-19	200.50		197.10(MH-S2)	12"	142'	1.00%
CB-20	201.00		197.10(MH-P)	12"	19'	1.05%
CB-21	201.25		197.68(MH-S)	12"	136'	0.50%
CB-22	200.50		197.25(MH-S)	12"	25'	1.00%
CB-22A	200.95		197.30(MH-Q)	12"	8'	1.25%
CB-22B	200.40		197.15(MH-S3)	12"	14'	0.49%
CB-23	200.95		197.38(MH-S4)	12"	63'	1.03%
CB-24	200.45		196.60(MH-R)	12"	7'	1.90%
CB-25	200.30		195.50(MH-U)	12"	164'	0.51%
CB-26	199.20		194.99(MH-T3)	12"	24'	2.02%
CB-27	201.25		196.00(MH-Q)	12"	78'	1.03%
CB-28	199.80		195.95(MH-U)	12"	7'	2.01%
CB-29	200.25		196.66(MH-S2)	12"	54'	0.50%
CB-30	202.05		200.50(MH-X)	12"	26'	26.40%
CB-31	199.50		195.44(MH-X)	12"	8'	2.00%
CB-32	199.50		195.50(MH-W)	12"	27'	1.00%
CB-33	200.00		194.86(TEE-2)	12"	33'	0.51%
CB-34	198.75		194.75(MH-Z)	12"	21'	1.03%
CB-35	199.60		195.80(MH-Y)	12"	16'	1.99%
CB-36	199.10		195.90(MH-A1)	12"	156'	1.00%
CB-37	199.05		195.70(MH-A1)	12"	15'	1.98%
CB-38	199.50		196.50(MH-C1)	12"	33'	2.00%
CB-39	199.50		196.50(MH-C1)	12"	8'	2.11%
CB-40	200.75	(4)	197.75(MH-C1)	12"	234'	1.00%
CB-41	199.70		195.00(MH-B14B) 196.30(MH-D1)	12"	18'	0.00% 0.77%
CB-42	199.70		196.33(MH-E1) 195.00(BASIN #14)	12"	9'	0.00% 0.00%
CB-43	201.25		195.70(MH-H1) 194.50(MH-B15)	15"	25'	3.98% 0.00%
CB-45	201.55		197.12(MH-K1)	12"	10'	0.98%
CB-46	201.85		198.35(MH-K1)	12"	131'	1.02%
--	--	--	--	--	--	--
CB-48	199.70		195.00(MH-F1) 195.00(BASIN #13)	15"	6'	0.00% 0.00%
CB-49	199.70		196.65(MH-G1)	15"	6'	2.51%
CB-50	199.85		196.43(MH-G1)	15"	70'	0.50%
CB-51*	199.00		196.03(MH-Q1*)	15"	141'	0.50%
CB-52*	199.00		195.43(MH-Q1*)	15"	7'	2.08%
CB-53*	198.00		195.04(MH-O1*)	15"	77'	1.04%
CB-54*	198.00		194.25(MH-N1*)	12"	11'	1.03%
CB-55*	198.00	194.50(MH-L1A*)	194.50(MH-M1*)	15"	10'	2.05%
CB-56*	198.40	194.50(MH-L1A*)	194.50(MH-L1)	12"	90'	1.26%
CB-57*	199.10		195.00(MH-S1*)	12"	81'	1.00%
CB-58	200.05		196.00(MH-R1)	12"	15'	0.99%
CB-59*	198.00		195.10(MH-T1*)	12"	96'	1.02%
CB-60*	198.00		194.38(MH-U1*)	12"	7'	0.99%
CB-61*	198.00		194.94(MH-V1*)	12"	10'	1.06%
CB-62*	198.10		195.31(MH-W1*)	12"	13'	0.99%
CB-63*	198.00		195.16(MH-W1*)	15"	129'	0.50%
CB-64*	199.50		195.71(MH-Z2)	12"	103'	0.50%
CB-66	199.35		196.63(FES-12A)	8"	55'	0.00%
CB-66(1)	199.35		196.63(FES-12B)	8"	55'	0.00%
CB-68	198.91		196.63(FES-11)	8"	16'	0.00%

ADDITIONAL DRAINAGE TABLE						
STR.	RIM GRT	INV. IN	INV. OUT	OUT. PIPE SIZE	PIPE LENGTH	OUT. PIPE SLOPE
MH-B14C	199.95	195.00(CB-44)				
CB-44	199.70		196.33(MH-E1A) 195.00(MH-B14C)	12"	8'	1.64% 0.00%
CB-45A	201.50		194.50(MH-B16)	12"	23'	0.00%
MH-B16	202.05	194.50(CB-43A)				
CB-45A	201.75		195.50(BASIN16A) 195.50(BASIN16B) 198.00(MH-L1)	12"	3'	0.00% 0.00% 1.69%
MH-E1A	199.80		195.06(MH-F1) 195.47(MH-A4) 197.75(CB-45A)	18"	49'	0.51% 0.00% 0.00%
MH-H1	202.28	--	195.47(MH-H1)	18"	134'	0.50%
--	--	--	--	--	--	--
R3A			196.90(R3B)	8"	53'	1.00%
R3B			195.79(MH-J)	12"	58'	1.00%
CB93	198.85		195.90(MH-R10B)	12"	11'	0.94%
CB94	199.50		196.50(MH-Z7)	12"	61'	0.98%
MH-Z7	200.98	195.90(CB-94)	195.80(MH-R10B)	15"	104'	0.96%
MH-R10C	202.20		196.90(MH-R10G)	15"	88'	0.51%
MH-R10D	202.60	197.00(R3C) 197.00(MH-R10C)	197.00(MH-R10C)	15"	150'	0.00%
MH-R10E	202.20	197.00(R10B)	197.00(MH-R10D)	15"	157'	0.00%
MH-R10G	202.42	196.45(MH-R10C)	196.35(MH-Z2)	15"	15'	0.66%
MH-WQUG	201.40	193.33(MH-WQUG)	193.33(MH-Z3)	15"	27'	1.21%

DRAINAGE TABLE						
STR.	RIM/ GRT	INV. IN	INV. OUT	OUT PIPE SIZE	PIPE LENGTH	OUT PIPE SLOPE
CB-69	200.50		196.60(MH-A5)	18"	42'	1.50%
CB-69A	201.00		197.50(MH-A5)	12"	54'	1.00%
CB-70*	198.45		195.95(MH-B2*) 194.50(MH-B4B*)	12"	8' 31'	0.98% 0.00%
CB-71*	198.45	194.50(B4*)	195.95(MH-C2*)	12"	8'	1.01%
CB-72*	198.45	194.50(TEE-1*)	195.95(MH-D2*)	12"	7'	1.99%
CB-73*	198.60		195.95(MH-G2*) 194.50(MH-BND-1*)	12"	8' 6'	2.48% 0.00%
CB-74*	198.00	194.50(B6*)	195.50(MH-Z1*)	12"	10'	0.98%
CB-75*	198.00		195.50(MH-Y1*) 194.50(MH-B6*)	12"	11' 5'	1.00% 0.00%
CB-76*	197.00		194.50(MH-G2*) 193.50(BND-4*)	12"	14' 0'	1.00% 0.00%
CB-77*	198.10		194.50(MH-H2*) 193.50(MH-B8*)	12"	11' 36'	1.05% 0.00%
CB-78*	199.10	194.50(B9*)	195.22(MH-H2)	12"	113'	1.00%
CB-79*	198.20	194.50(B10*)	195.70(MH-F2*)	12"	59'	1.00%
CB-80*	198.20	194.50(B11A*)	195.70(MH-F2*)	12"	8'	1.08%
CB-81*	198.20	194.50(BND-5*)	195.70(MH-E2*)	12"	9'	1.05%
CB-82	200.75	195.50(B12A)	198.25(MH-N2)	12"	13'	2.02%
CB-83	200.85	195.50(B12B)	198.25(MH-N3)	12"	14'	0.98%
CB-84	201.00	197.20(YD-3)	196.69(MH-Q2)	12"	81'	0.51%
CB-85	201.00		196.69(MH-Q2)	12"	10'	1.06%
CB-86	198.75		194.93(MH-U)	12"	22'	1.23%
CB-87*	198.60		195.15(MH-V2)	12"	12'	1.00%
CB-88*	198.80	194.50(B5*)	196.30(MH-HR2*)	12"	6'	0.95%
CB-89	200.50		197.50(FES-9)	12"	149'	0.45%
CB-90	202.24		198.00(MH-B3)	12"	20'	1.00%
CB-91	201.00		197.00(MH-T3)	12"	7'	2.00%
CB-92	200.05		196.10(MH-S5)	12"	5'	2.00%
FES-1		191.70(WDIV2-B)				
FES-2		192.00(WDV1-B)				
FES-3		192.91(MH-V)				
FES-4		192.40(MH-C1)				
FES-5		189.51(MH-S1*)				
FES-6		191.34(MH-L1*)				
FES-7			198.50(MH-H)	18"	105'	2.50%
FES-8		197.00(MH-HR2*)				
FES-9		196.83(CB-89)				
FES-10		193.07(MH-A1)				
FES-11		196.83(CB-68)				
FES-12A		196.83(CB-66)				
FES-12B		196.83(CB-66 (1))				
MH-A	201.90	198.11(CB-2) 198.11(MH-A4)	198.11(MH-B1)	18"	62'	0.50%
MH-A1	199.60	194.30(CB-37) 194.32(CB-36)	194.32(FES-10)	15"	124'	1.00%
MH-A2	201.65	195.55(MH-A3) 195.55(11F)	195.55(MH-A5)	18"	20'	1.01%
MH-A3	202.10	197.60(R1G)	197.60(MH-A2)	12"	106'	0.99%
MH-A4	201.80	198.49(CB-1) 188.50(CB-1A)	198.49(MH-A5)	15"	75'	0.51%
MH-A5	201.20	196.96(CB-65A) 195.97(CB-69) 196.35(MH-A2)	195.97(MH-H)	18"	36'	0.61%
MH-A6	201.75	199.57(BND-30)	199.57(MH-B1B)	12"	207'	0.52%
MH-B	202.85	196.35(CB-3) 196.35(MH-Y2) 196.83(MH-B)	196.09(MH-B3)	24"	84'	0.50%
MH-B1	201.65	198.37(CB-2A) 197.80(MH-A)	197.80(MH-B)	18"	190'	0.50%
MH-B1A	203.60	198.49(BND-31)				
MH-B1B	202.70	198.00(MH-A6)				
MH-B2*	198.65	195.89(CB-70*) 193.29(MH-C2*)	193.29(MH-HR2*)	18"	77'	0.50%
MH-B3	202.65	195.67(MH-B) 197.80(CB-9)	195.67(MH-C)	24"	97'	0.50%
MH-B4A*	198.54		194.50(TEE-1*)	8"	14'	0.00%
MH-B4B*	198.50	194.50(CB-70*)				
MH-B6*	198.10	194.50(CB-75*)				
MH-B7*	197.40	193.50(BND-3*)				
MH-B8*	198.10	193.50(CB-77*)				

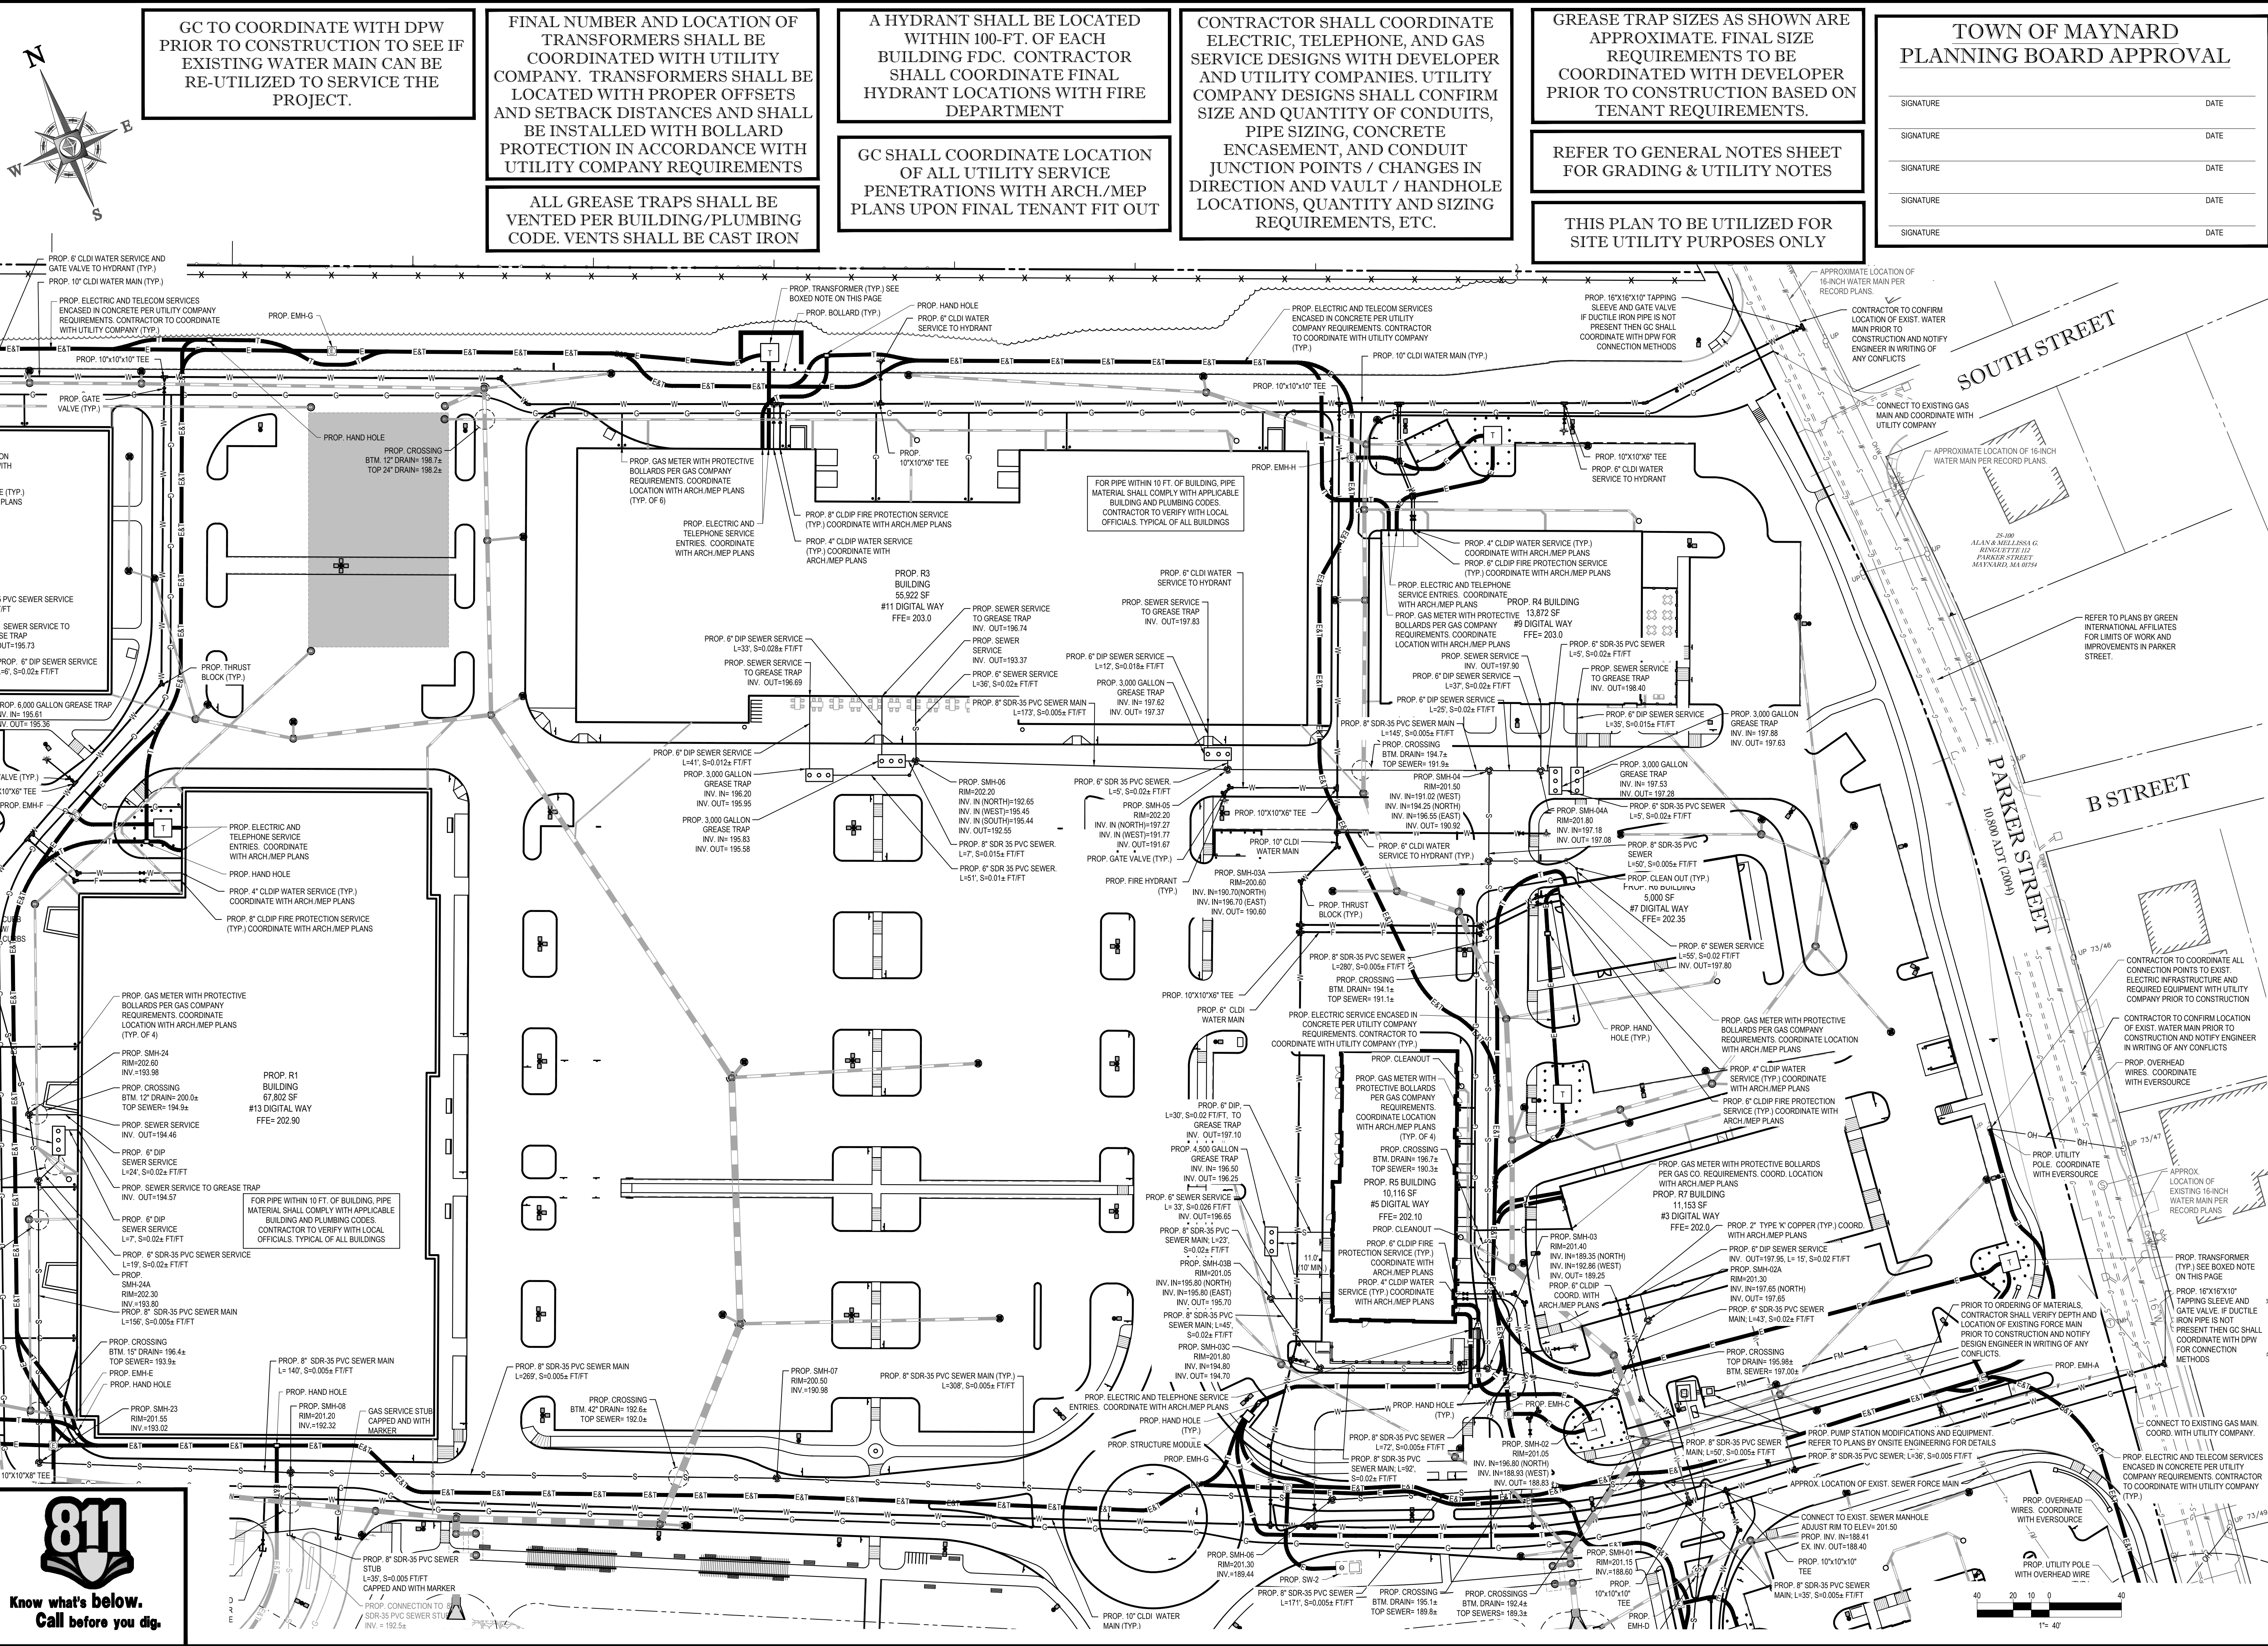

BOHLER ENGINEERING

SITE UTILITY AND CONSTRUCTION DOCUMENTS
LAND SURVEYING PROGRAM MANAGEMENT PERMITTING SERVICES SUSTAINABLE DESIGN (FULL SET)
UTAH NEW YORK
LEHIGH VALLEY PA
REHOBOTH BEACH DE
BOSTON MA
SOUTH FLORIDA
NORTHERN VIRGINIA
NEW JERSEY NY
NEW YORK NY

REVISIONS

REV	DATE	COMMENT	BY
4	06/28/17	DRAINAGE REVISIONS (FULL SET)	AWP
5	07/26/17	REV. PER TOWN COMMENTS	AWP
6	08/10/17	PEER REVIEW COMMENTS	CFD
7	09/18/17	CONSTRUCTION DOCUMENTS	AWP
8	11/06/18	REVISED R9 / R10 PAD	CFD
9	12/10/18	REV. PER TOWN COMMENTS	CFD
10	04/23/19	REVISED R9 / R10 PAD	CMC
10A	05/13/19	REVISED PER TOWN COMMENTS	CFD
10B	07/25/19	REVISED PER TOWN COMMENTS	CMC
13	10/04/19	REVISED R4-R8 PAD	BPB
13A	11/12/19	REVISED MARKET BASKET LOADING AREA	BPB
13B	11/13/19	REVISED R8 PAD PER BPB COMMENTS	BPB
13C	11/25/19	REVISED R8 PAD	BPB
13D	01/09/20	REVISED R8 PAD	BPB
15	01/16/20	REVISED R4-R7 PAD	BPB

PRELIMINARY

PROJECT: SITE DEVELOPMENT PLANS FOR MAYNARD CROSSING

LOCATION OF SITE: MAP #25 & LOTS #152 & 152-1 129 PARKER STREET (ROUTE 27) TOWN OF MAYNARD MIDDLESEX COUNTY MASSACHUSETTS

BOHLER ENGINEERING

352 TURNPIKE ROAD
SOUTHBOROUGH, MA 01772
Phone: (508) 480-9900
Fax: (508) 480-9980
www.BohlerEngineering.com

J.A. KUCICH


JOHN A. KUCICH
Professional Engineer
No. 41530
State of Massachusetts
Civil Engineering

UTILITY PLAN "B"

SHEET NUMBER: 18 OF 37


REV 15 - 01/16/2020

P:\10161160\Drawings\Plan_Sewer\REV 15\10161160.dwg, 16-MAR-20, 4:26:00 PM, Library, Xref\05-10-17.dwg, User:BOA, 10-36002907

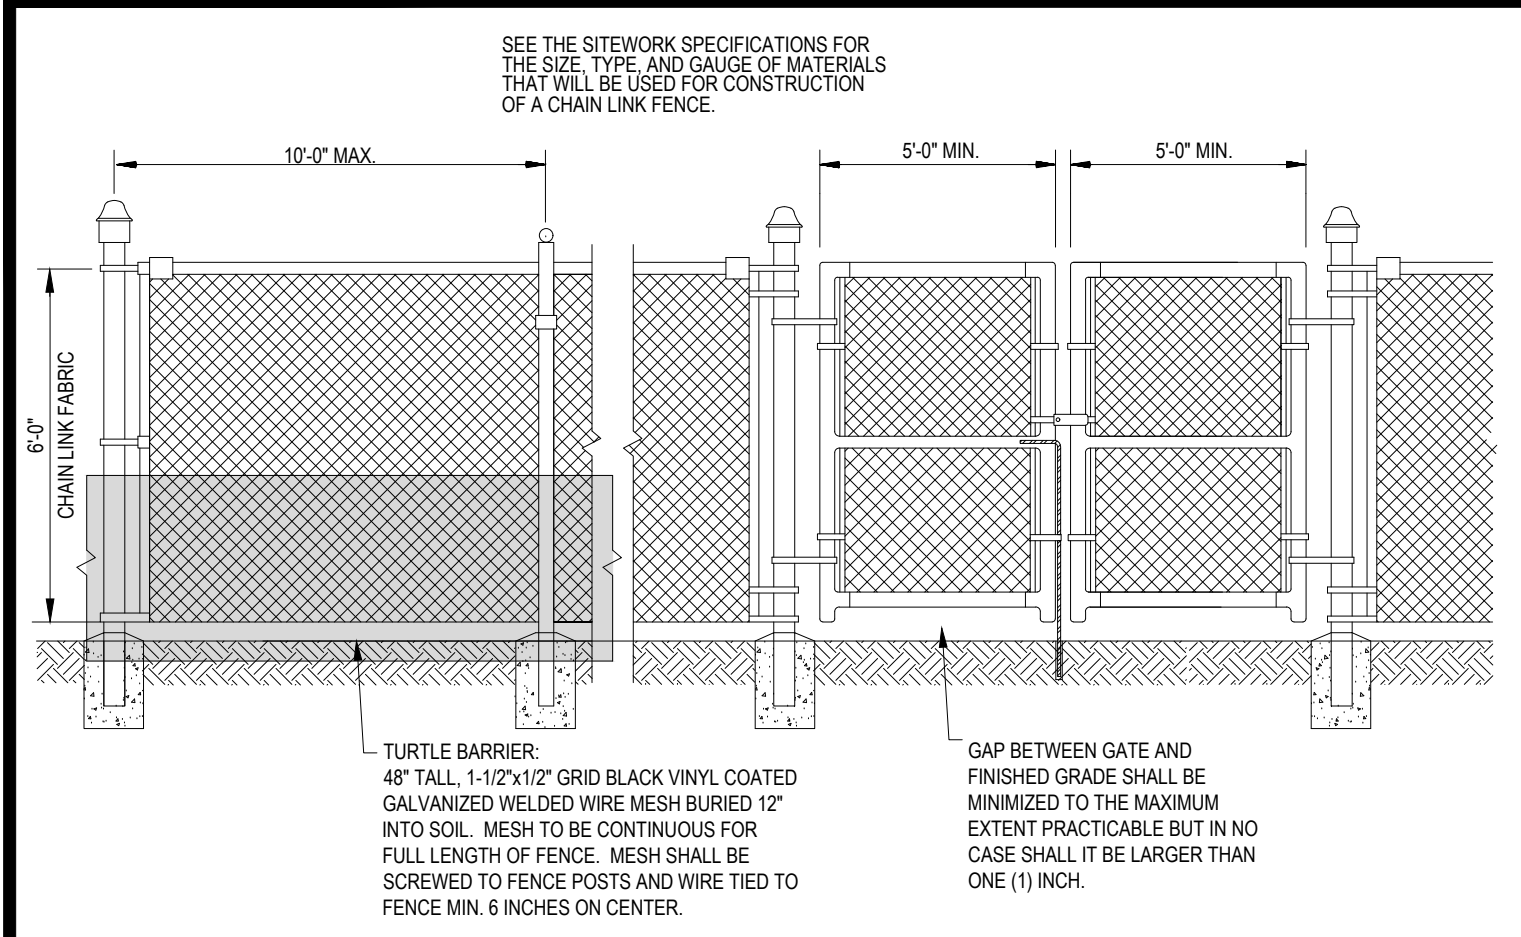


TURTLE BARRIER FENCE DETAIL

N.T.S.

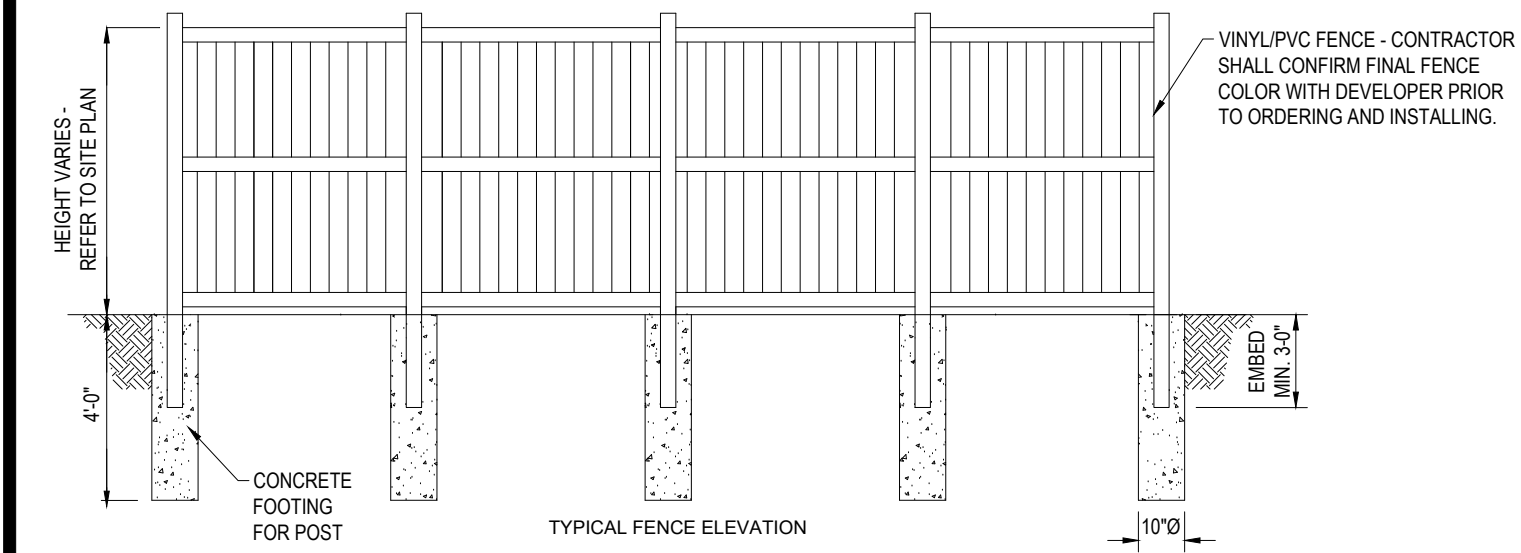


VINYL FENCE DETAIL

N.T.S.

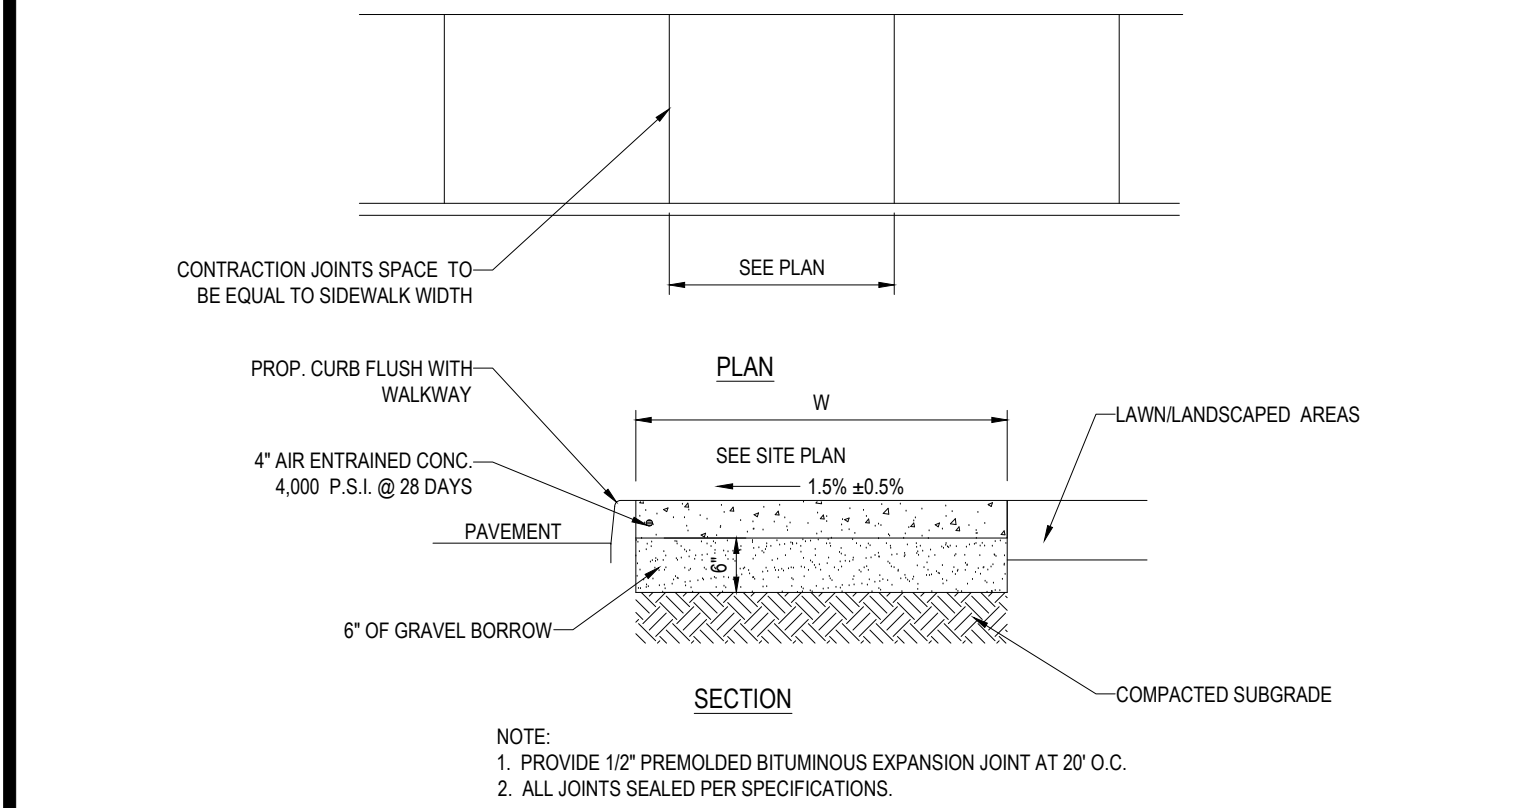


ON-SITE SIDEWALK DETAIL

N.T.S.

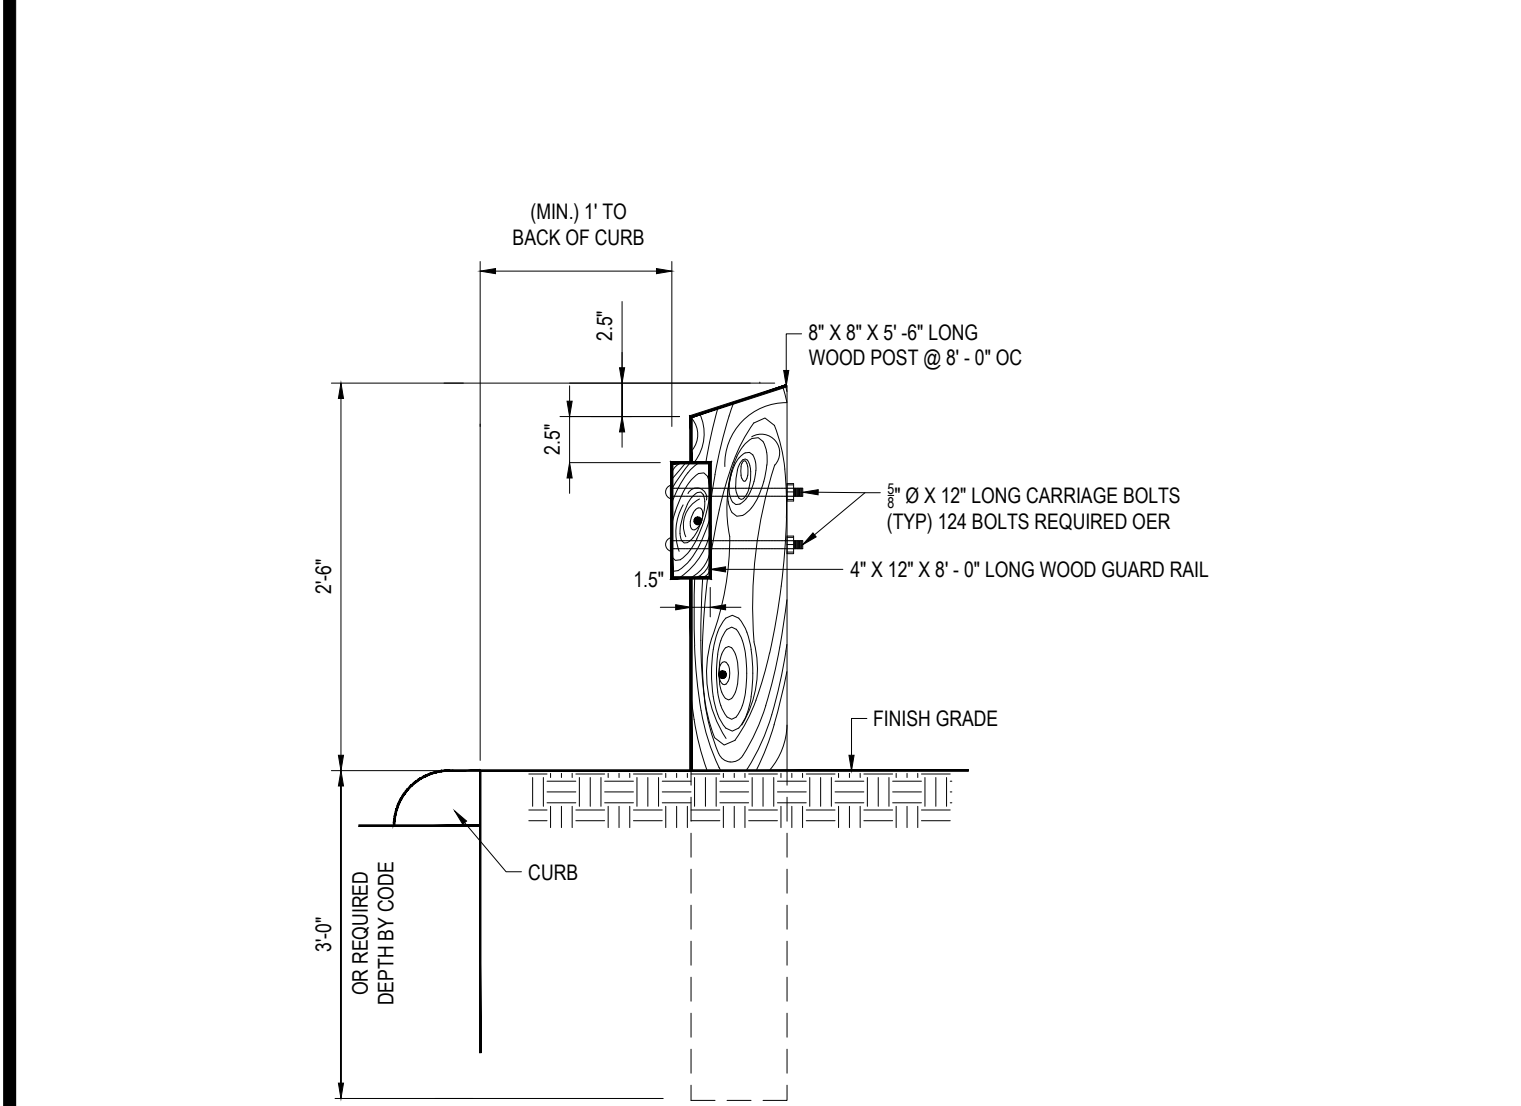


WOOD GUIDERAIL

N.T.S.

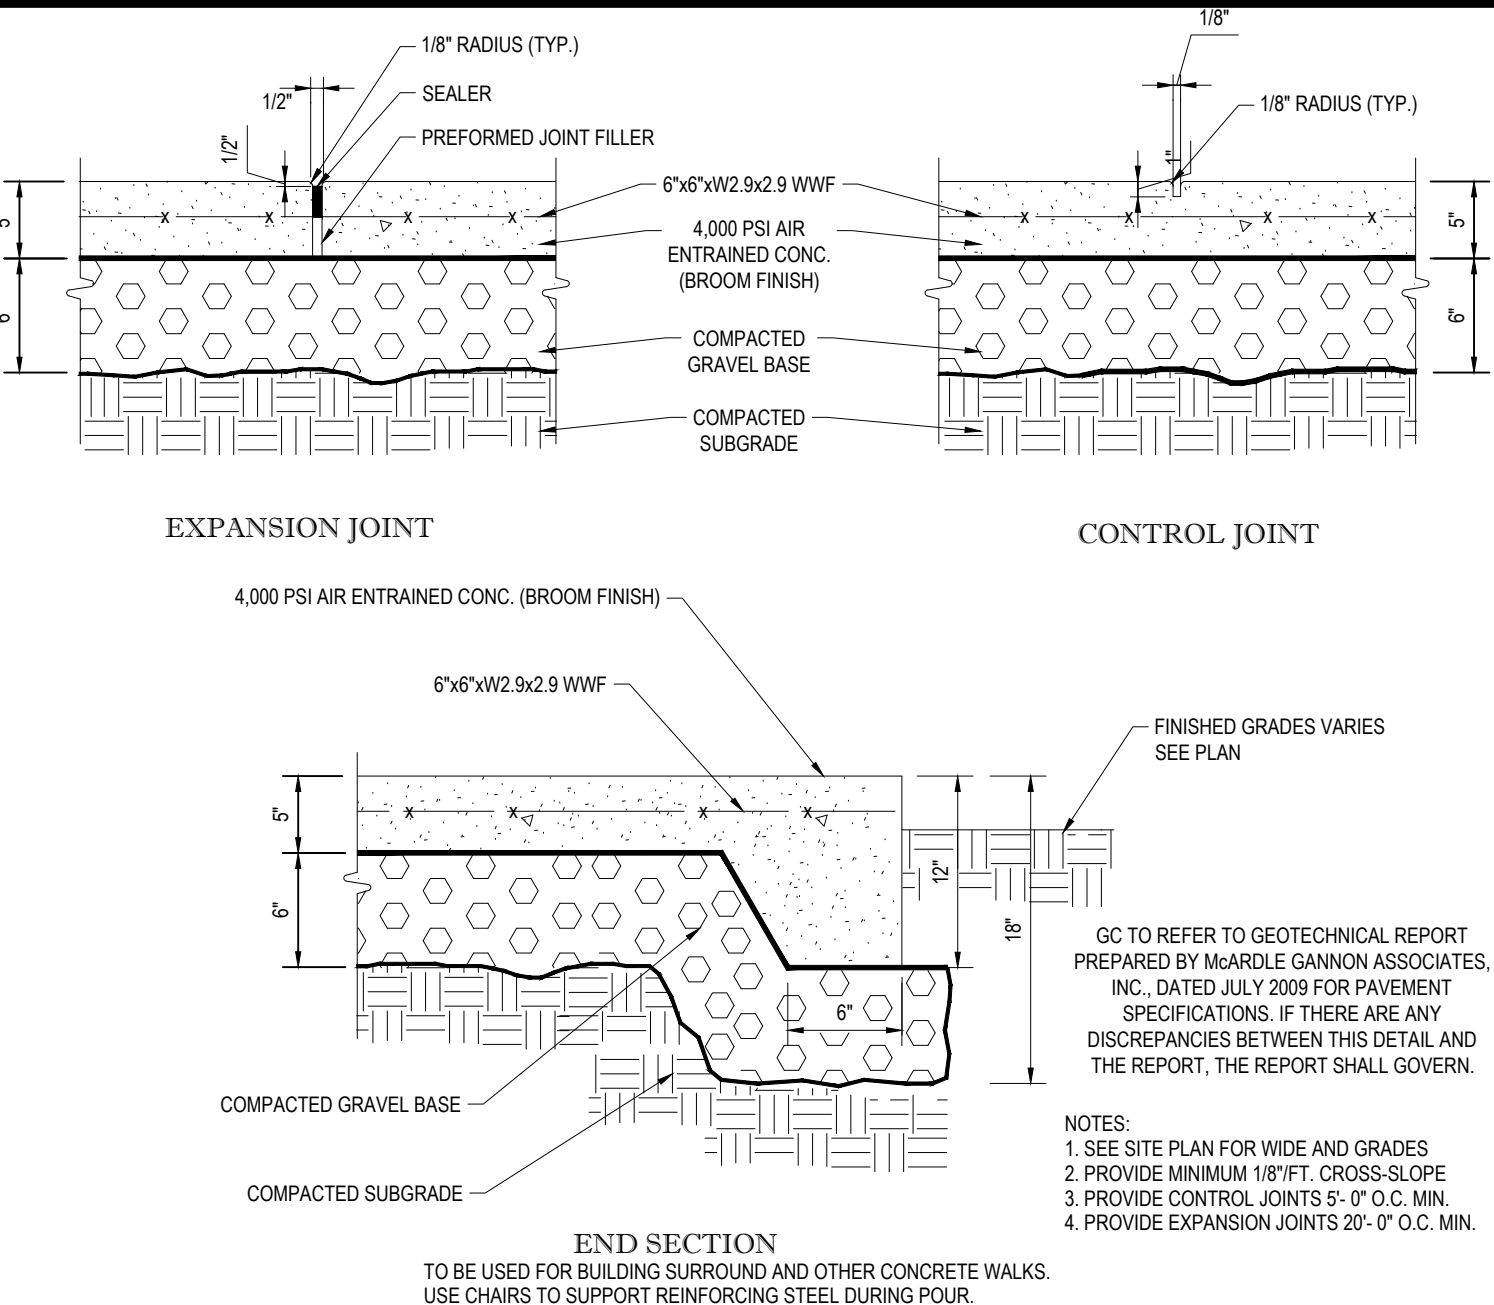

CONCRETE SIDEWALK DETAILS


N.T.S.

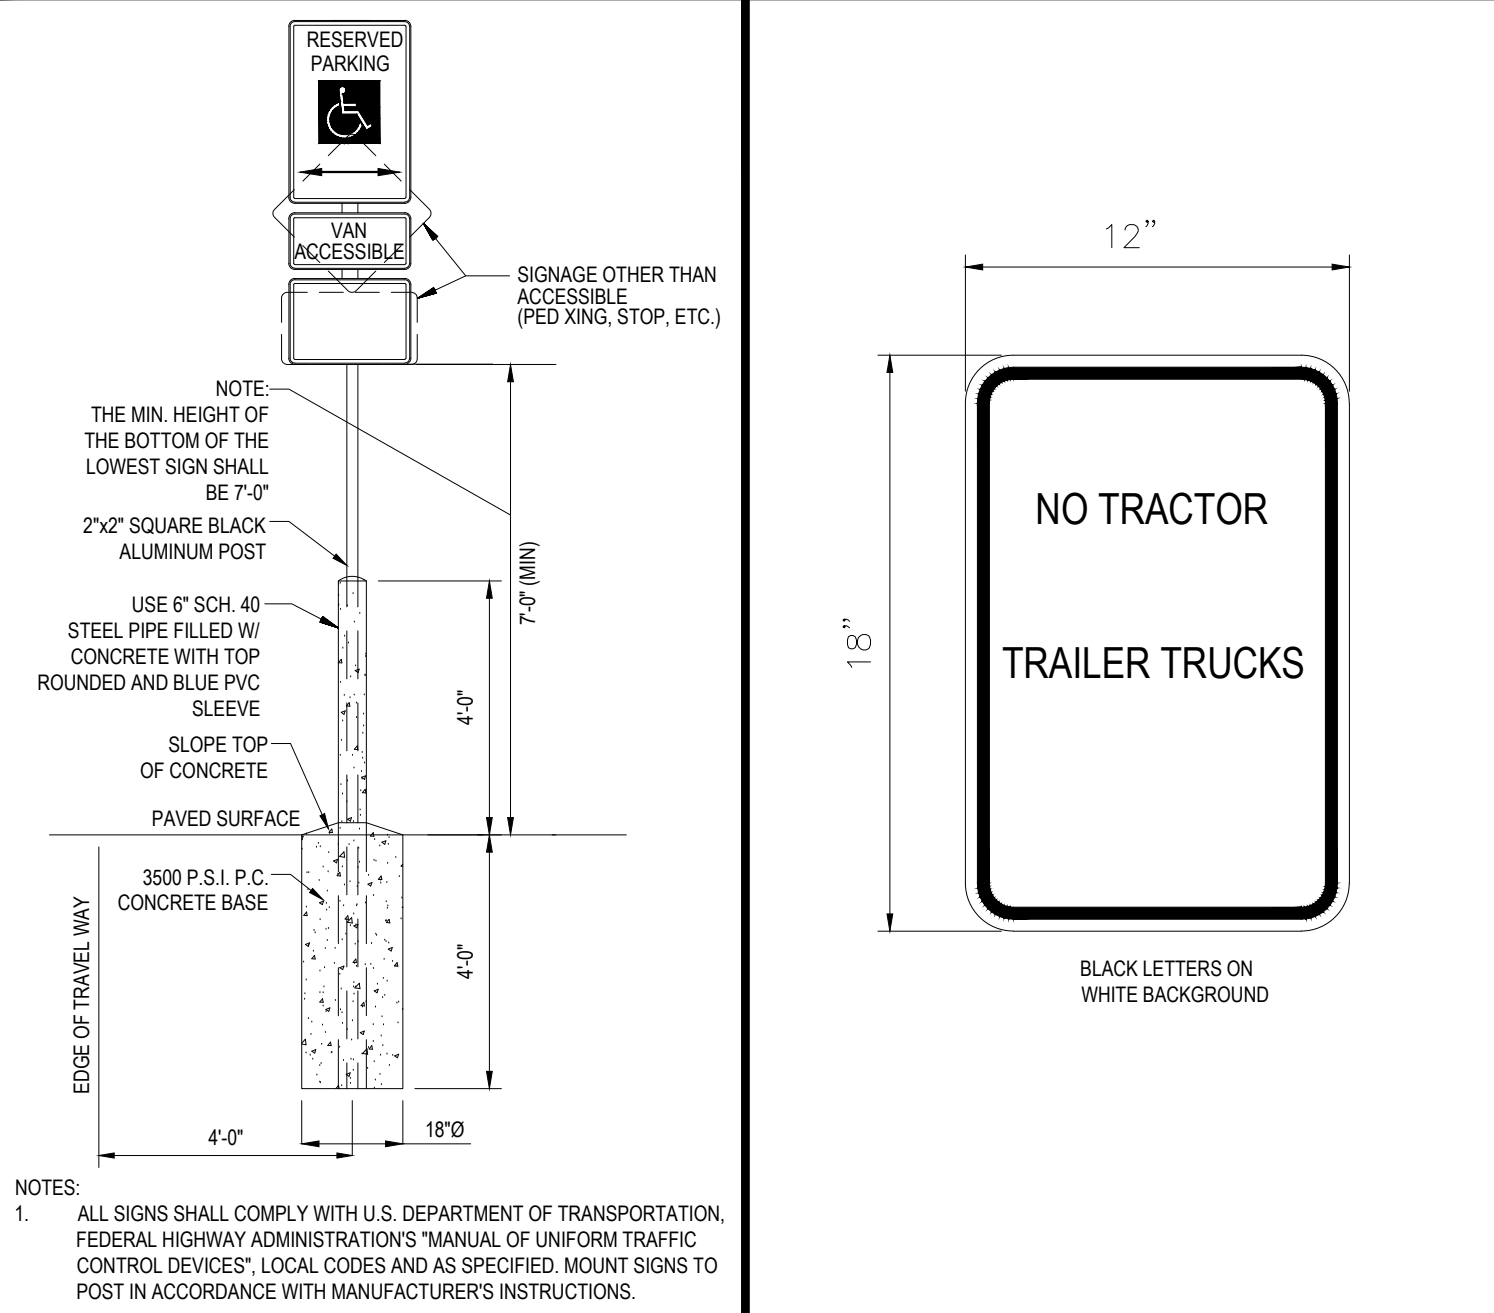

ACCESSIBLE PARKING SIGN


"NO TRACTOR TRAILER TRUCK" SIGN

N.T.S.

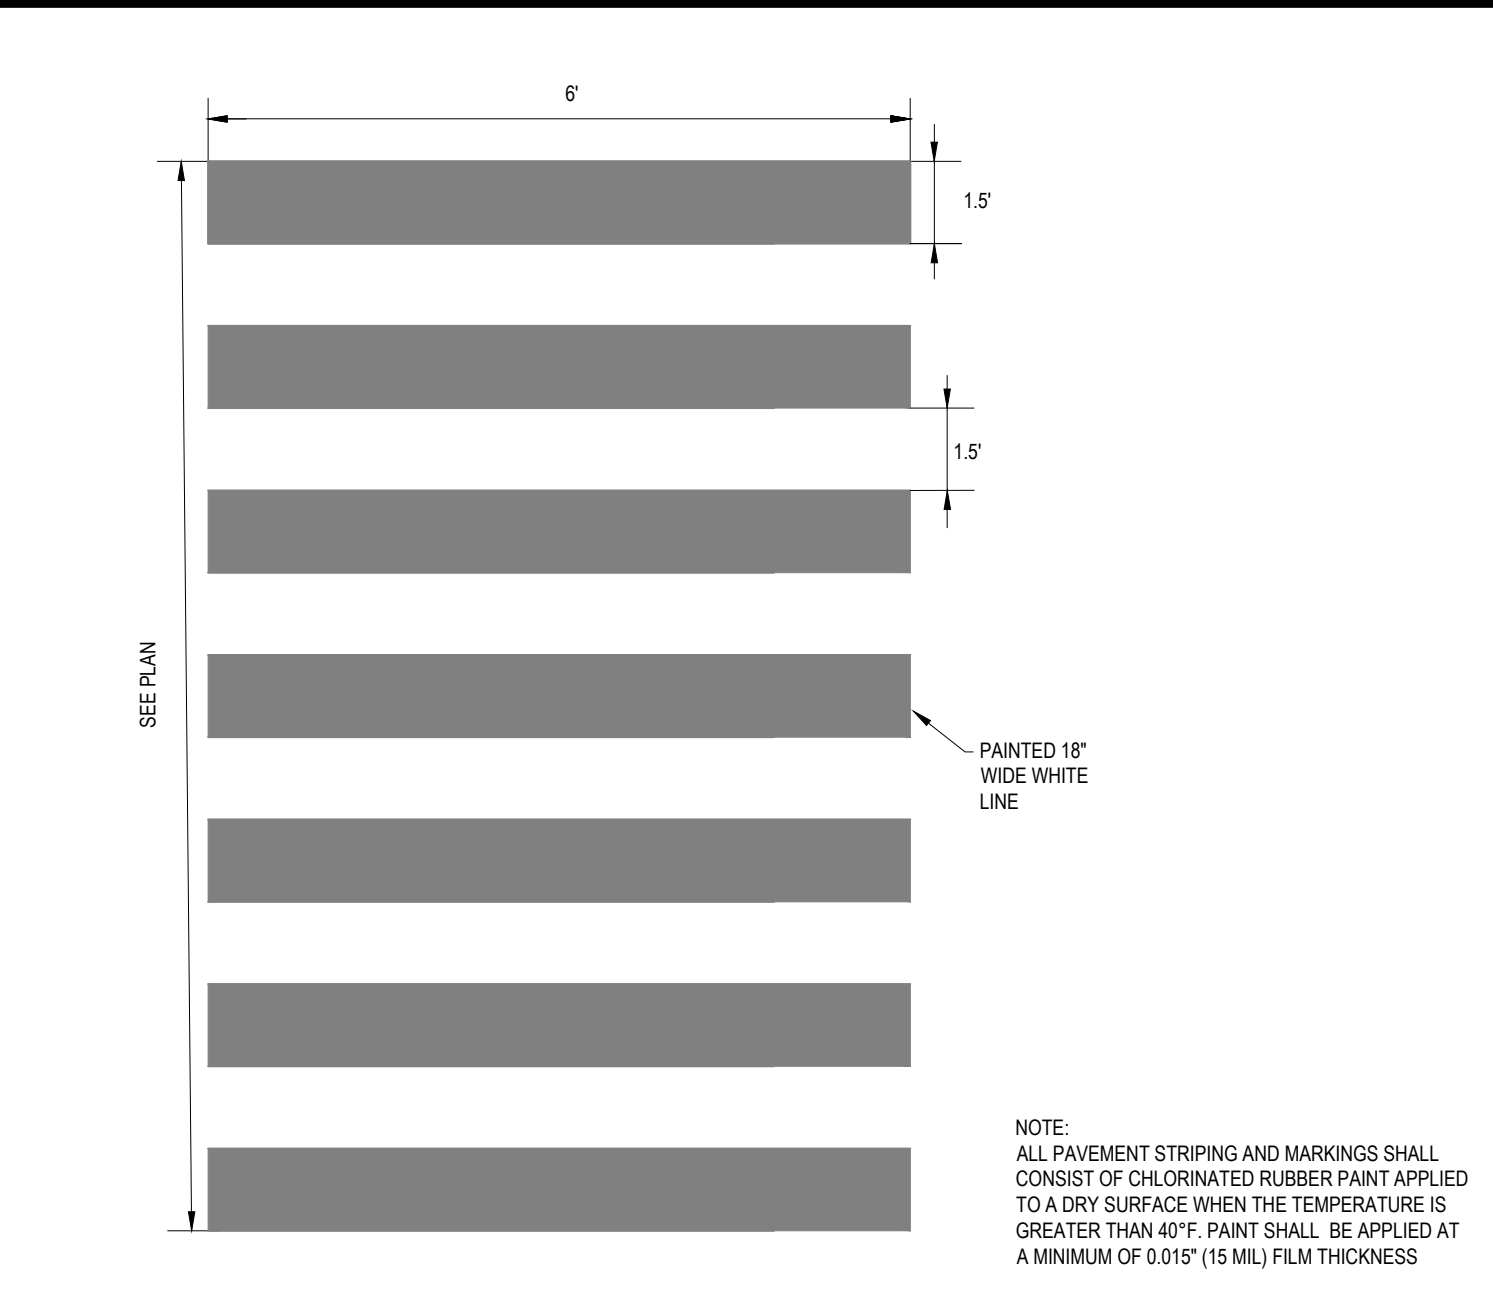


CROSSWALK DETAIL

N.T.S.

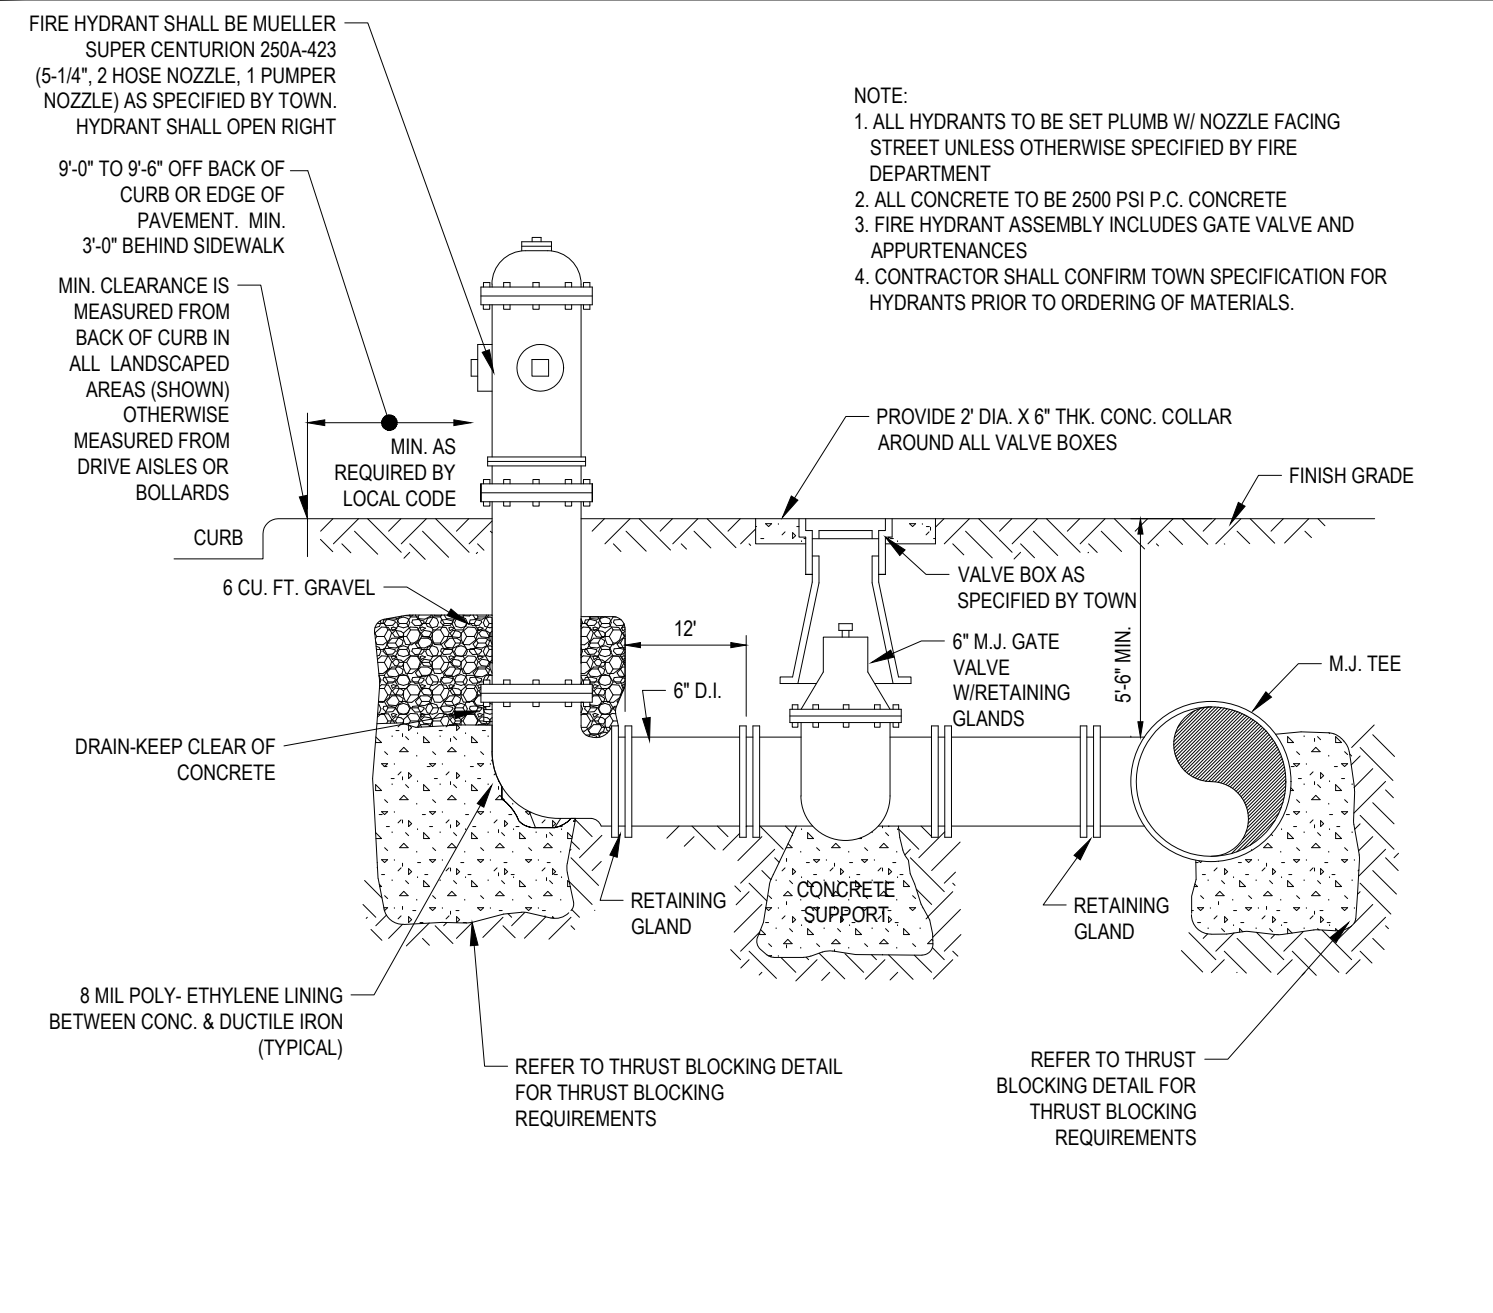


FIRE HYDRANT ASSEMBLY

N.T.S.

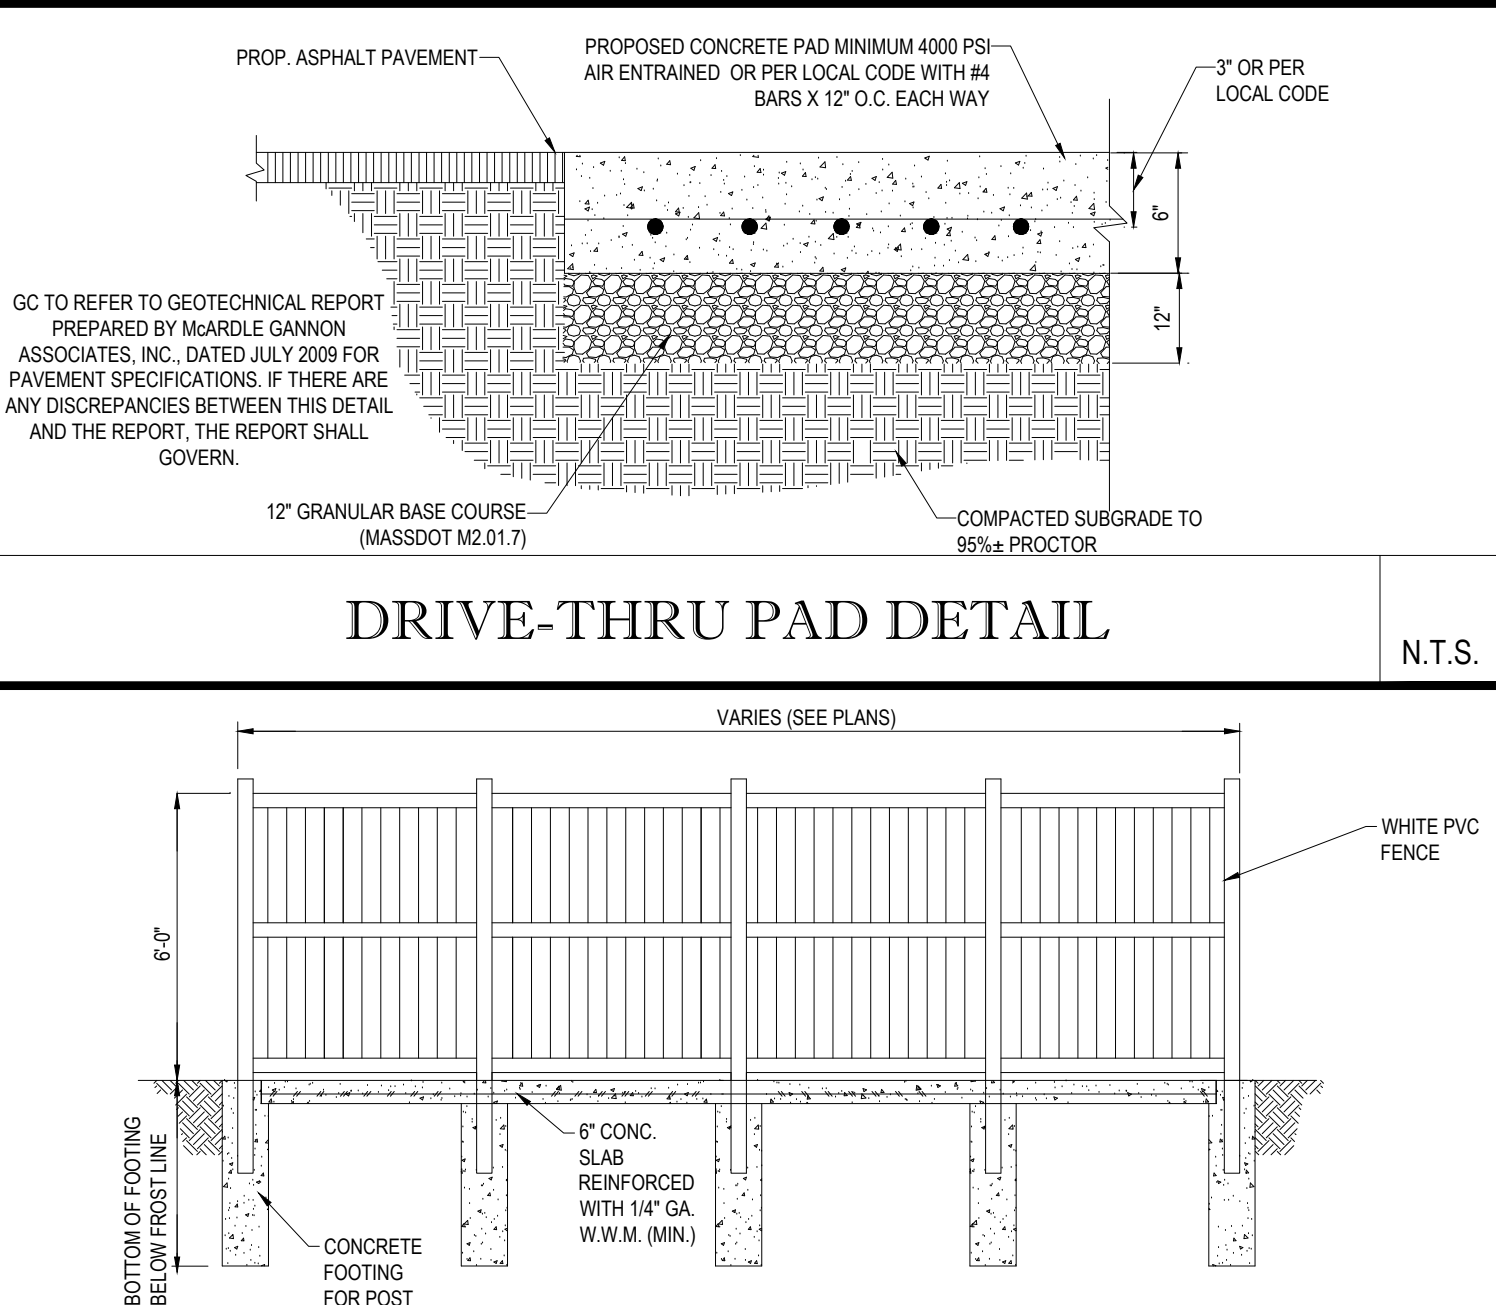


DRIVE-THRU PAD DETAIL

N.T.S.

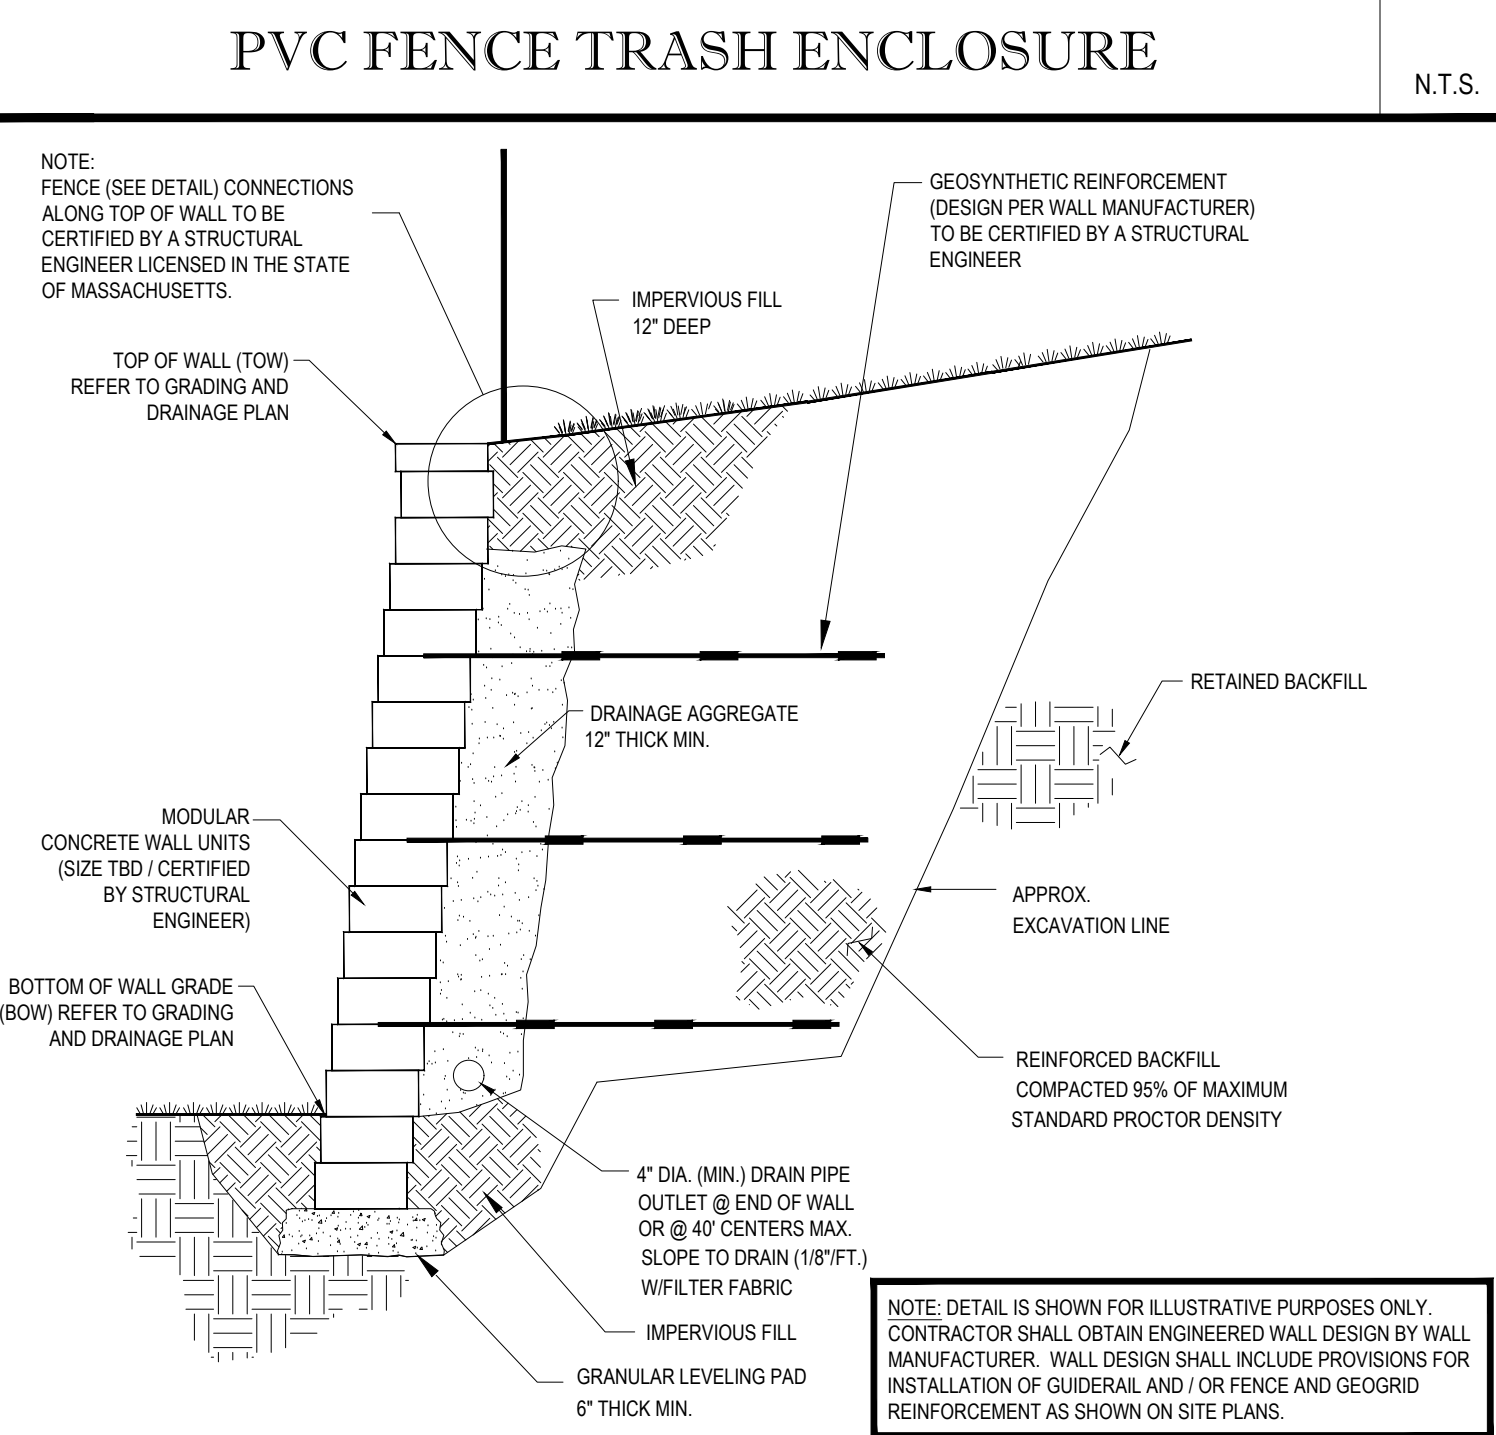


PVC FENCE TRASH ENCLOSURE

N.T.S.

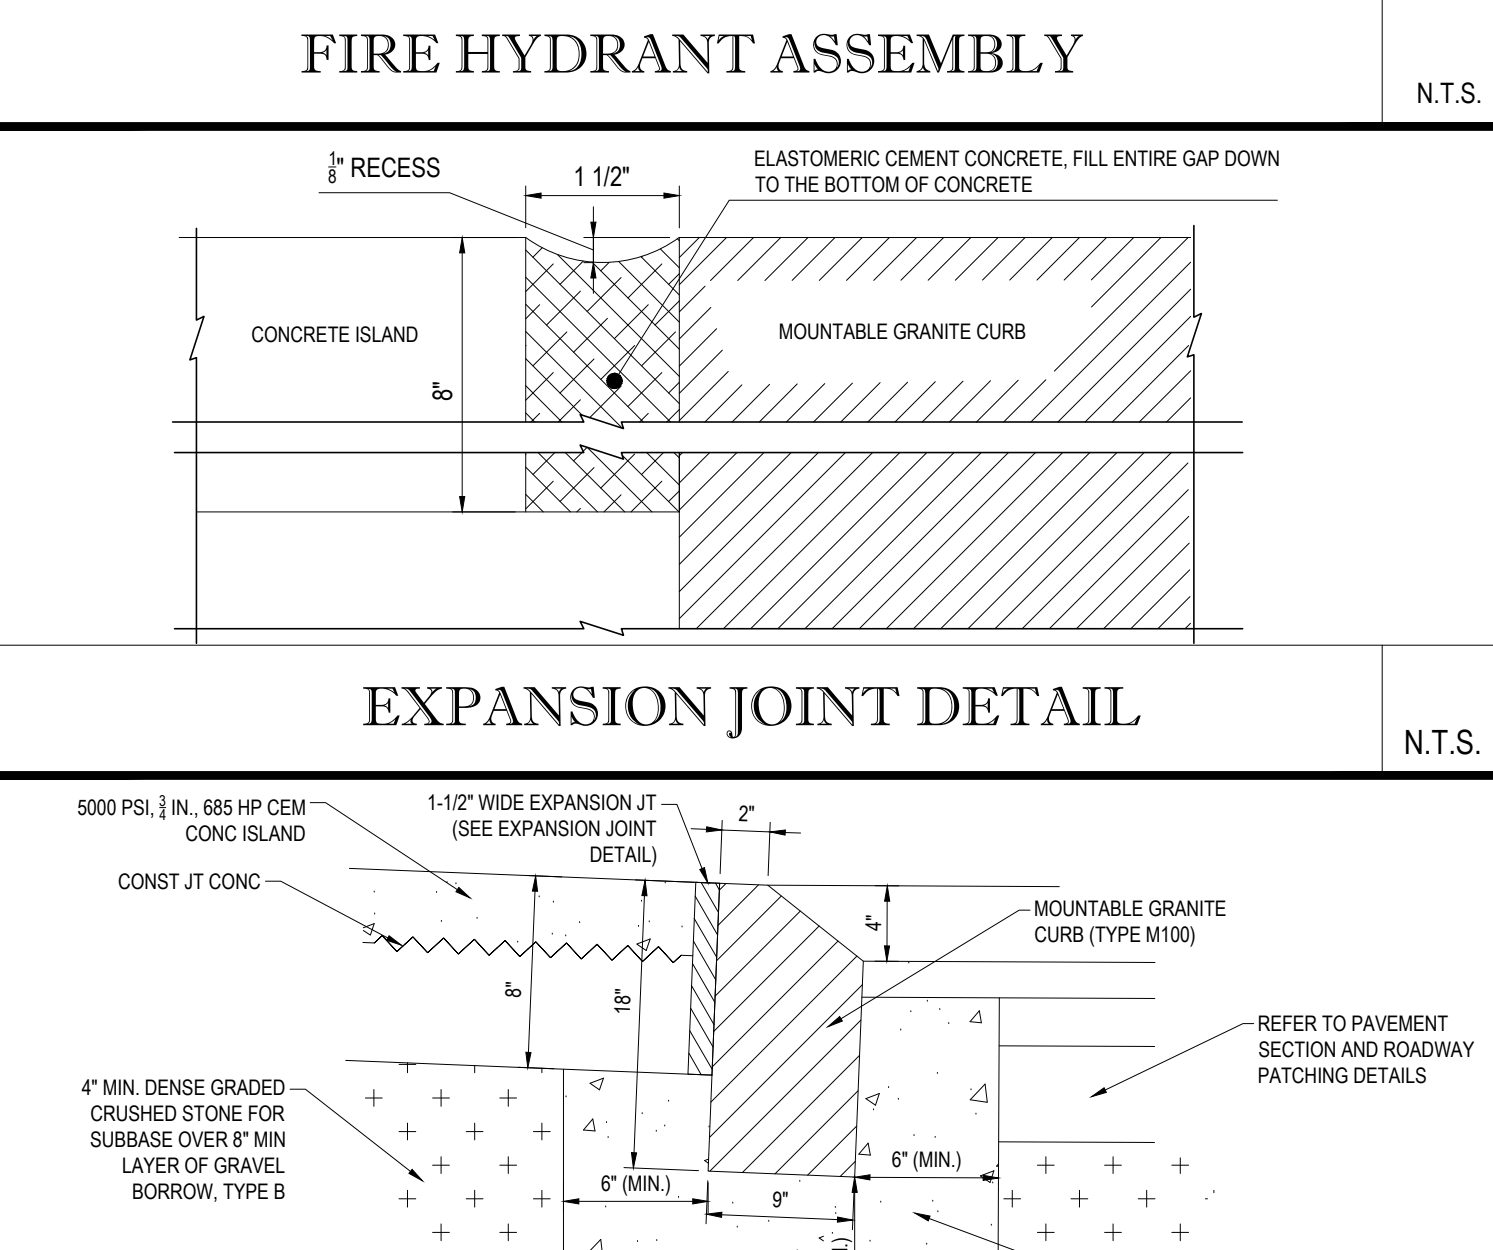

EXPANSION JOINT DETAIL

N.T.S.

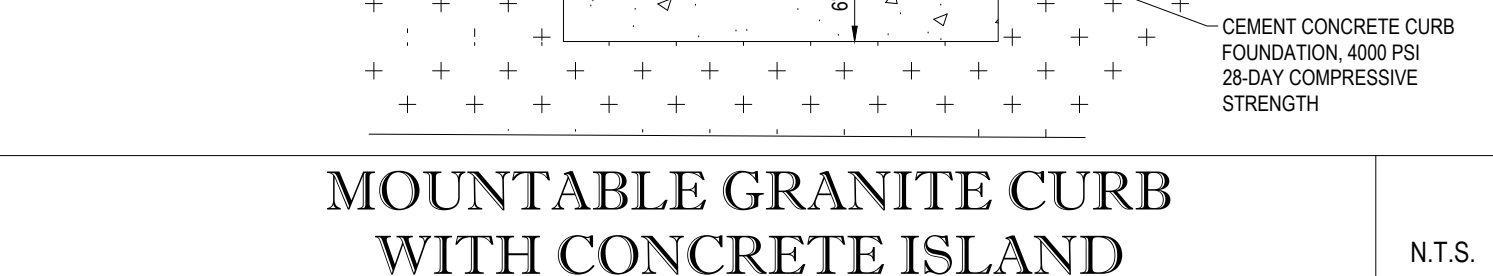

MOUNTABLE GRANITE CURB WITH CONCRETE ISLAND

N.T.S.

CONCRETE TO BE RAISED FOR PROPER WATER RUN OFF

4" DIAMETER STEEL PIPE FILLED W/ CONC. AND YELLOW PVC SLEEVE (SEE SPEC.) AND EMBEDDED IN CONC. BASE

BITUMINOUS JOINT AROUND PIPE

TOP OF SLAB OR ASPHALT

LEAVE SPACE FOR 2" SAND OR STYROFOAM LAYER BETWEEN TOP OF FOOTING & BOTTOM OF SLAB

NOTE: BOLLARDS REQ'D AT BLDG CORNERS, FIRE HYDRANTS, WATER METER, GAS METER, SPRINKLER RISER, TRANSFORMERS & ALL UTILITIES AT LOCATIONS SHOWN ON THESE DRAWINGS INTERIOR & EXTERIOR.

3000 PSI (MIN.) CONCRETE

TOWN OF MAYNARD
PLANNING BOARD APPROVAL

SIGNATURE	DATE
SIGNATURE	DATE
SIGNATURE	DATE
SIGNATURE	DATE
SIGNATURE	DATE

BOHLER ENGINEERING

1000 W. 10TH STREET, SUITE 100
DALLAS, TEXAS 75201
PHONE: (214) 635-1111
FAX: (214) 635-1112
WWW.BOHLENERG.COM

REVISIONS

REV	DATE	COMMENT	BY
4	06/28/17	DRAINAGE REVISIONS (FULL SET)	AWP
5	07/26/17	REV. PER TOWN COMMENTS	AWP
6	08/10/17	PEER REVIEW COMMENTS	CFD
7	09/18/17	CONSTRUCTION DOCUMENTS	AWP
8	11/06/18	REVISED R9 / R10 PAD	CFD
9	12/10/18	REV. PER TOWN COMMENTS	CFD
10	04/23/19	REVISED R9 / R10 PAD	CMC
10A	05/13/19	REVISED PER TOWN COMMENTS	CFD
10B	07/25/19	REVISED PER TOWN COMMENTS	CMC
13	10/04/19	REVISED R4-R8 PAD	BPB
13A	11/12/19	REVISED MARKET BASKET LOADING AREA	BPB
13B	11/13/19	REVISED R8 PAD PER BPB COMMENTS	BPB
13C	11/25/19	REVISED R9 PAD	BPB
13D	01/09/20	REVISED R8 PAD	BPB
15	01/16/20	REVISED R4-R7 PAD	BPB

PRELIMINARY

PROJECT No.: W161189
DRAWN BY: AWP/CFD
CHECKED BY: NEM/JAK
DATE: 02/15/2017
SCALE: AS NOTED
CAD I.D.: W161189S15 DETAILS

PROJECT: SITE DEVELOPMENT PLANS FOR

CAPITAL GROUP PROPERTIES

MAYNARD CROSSING

LOCATION OF SITE
MAP #25 & LOTS #152 & 152-1
129 PARKER STREET (ROUTE 27)
TOWN OF MAYNARD
MIDDLESEX COUNTY
MASSACHUSETTS

BOHLER ENGINEERING
352 TURNPIKE ROAD
SOUTHBOROUGH, MA 01772
Phone: (508) 480-9900
Fax: (508) 480-9080
www.BohlerEngineering.com

J.A. KUCICH
JOHN A. KUCICH
CIVIL ENGINEER
No. 41530
MASS. REG. PROFESSIONAL ENGINEER
1980
1000 W. 10TH STREET, SUITE 100
DALLAS, TEXAS 75201
PHONE: (214) 635-1111
FAX: (214) 635-1112
WWW.BOHLENERG.COM

SHEET TITLE: CONSTRUCTION DETAIL SHEET

SHEET NUMBER: 27 OF 37

REV 15 - 01/16/2020